

Copyright of James Barr. All Rights Reserved.
Do not scale from this drawing. If in any doubt, ask.

James Barr

220 West George Street, Glasgow, G2 2LN
Tel: 0141 300 8000
Fax: 0141 300 8001
e: enquiries@jamesbarr.co.uk
www.jamesbarr.co.uk

Job Title
Burn Stewart
Ledaig Distillery,
Tobermory,
Isle of Mull

Drawing title
Shop plan, elevation and
location plan


Scale	Sheet size	Date	Drawn:
As indicated	A2	26.05.08	GB
Job number			
046203			
Drawing Number			
B48293	(EX) 04		
Revision			

starwalker creative

Job Title:
Tobermory Distillery
'Ledaig Lane'
Isle of Mull

GARDEN

SHOP

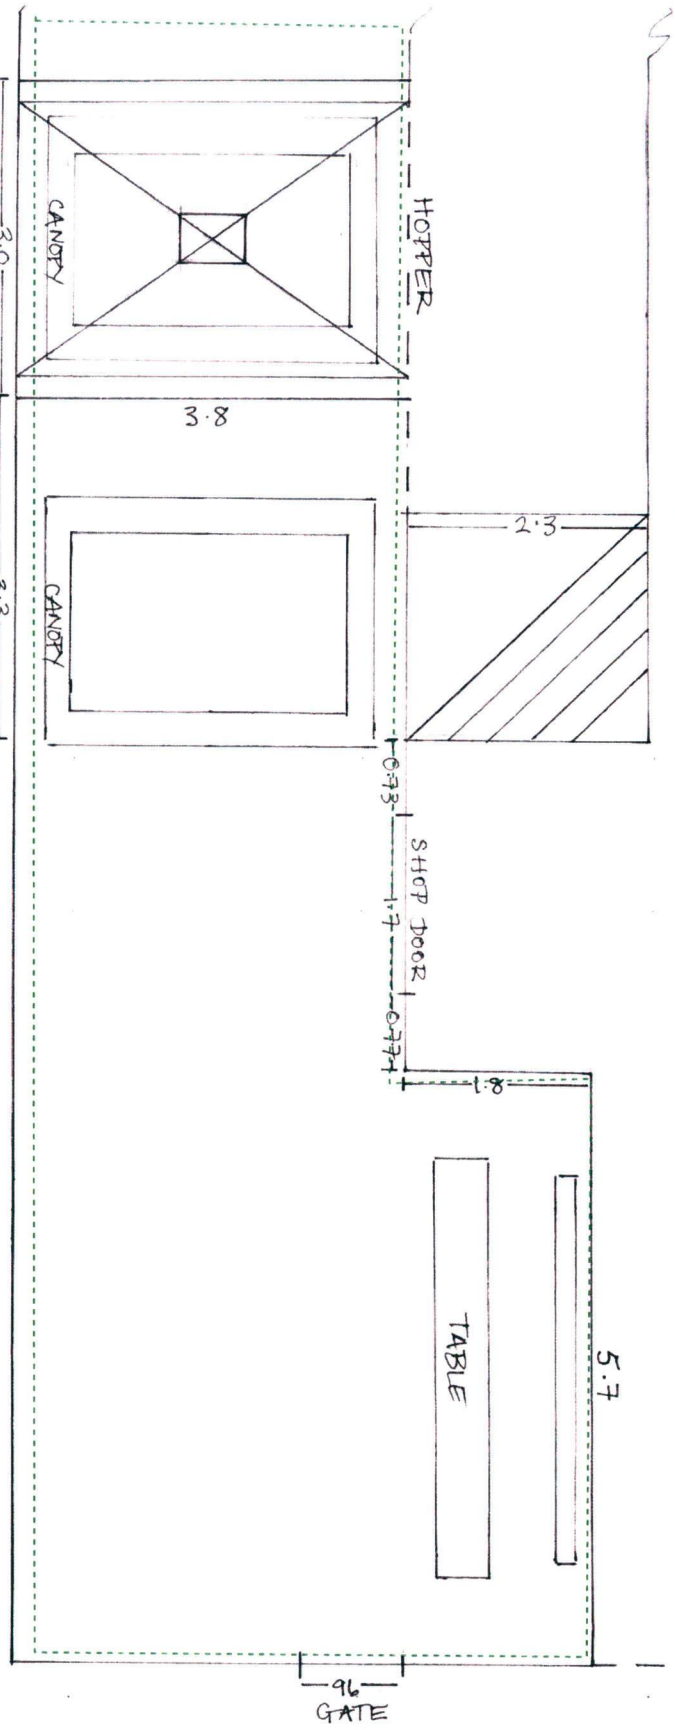

PLAN


Children and Young Persons Access

HEIGHT OF HOPPER APPROX 7m

MOVABLE CANDY AND CASKS

MOVABLE CANDY AND CASKS

ELEVATION

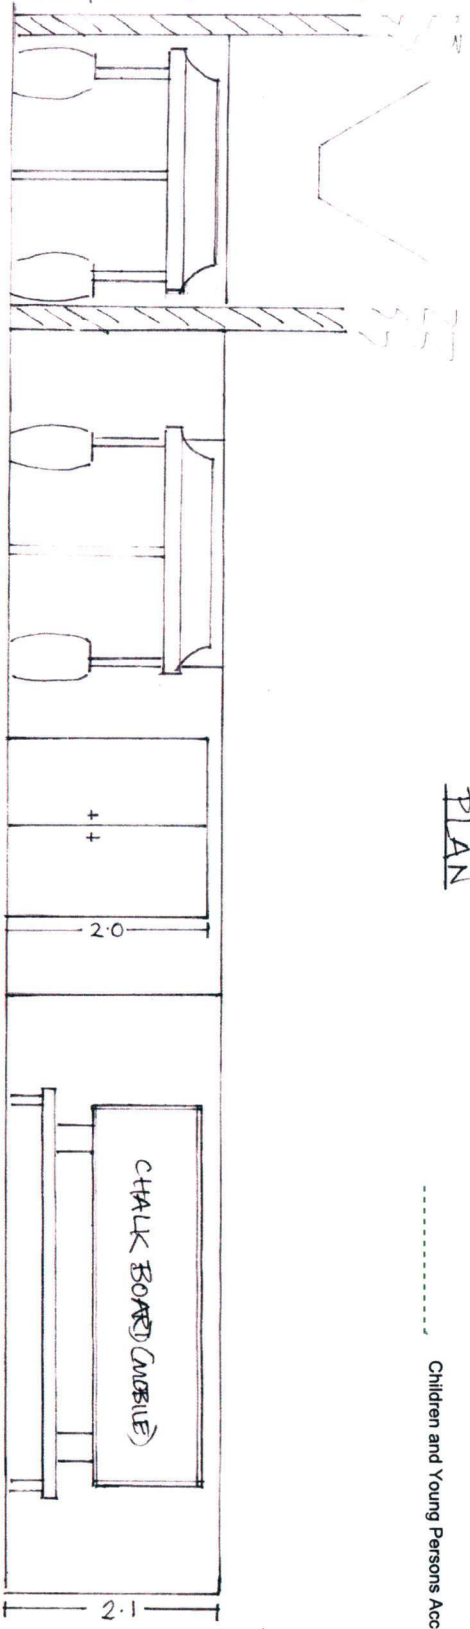

Scale: 1:50

Date: 01.06.18

Drawn: DMcK

Job

Number:


06011810

Electrical legend

- Fire alarm device
- Manual call point
- Manual call point (MCP)
- Smoke detector
- Standalone device

Legend Lines

- Outdoor Area - Distillery Compound
- Outdoor Area - Young Persons Access

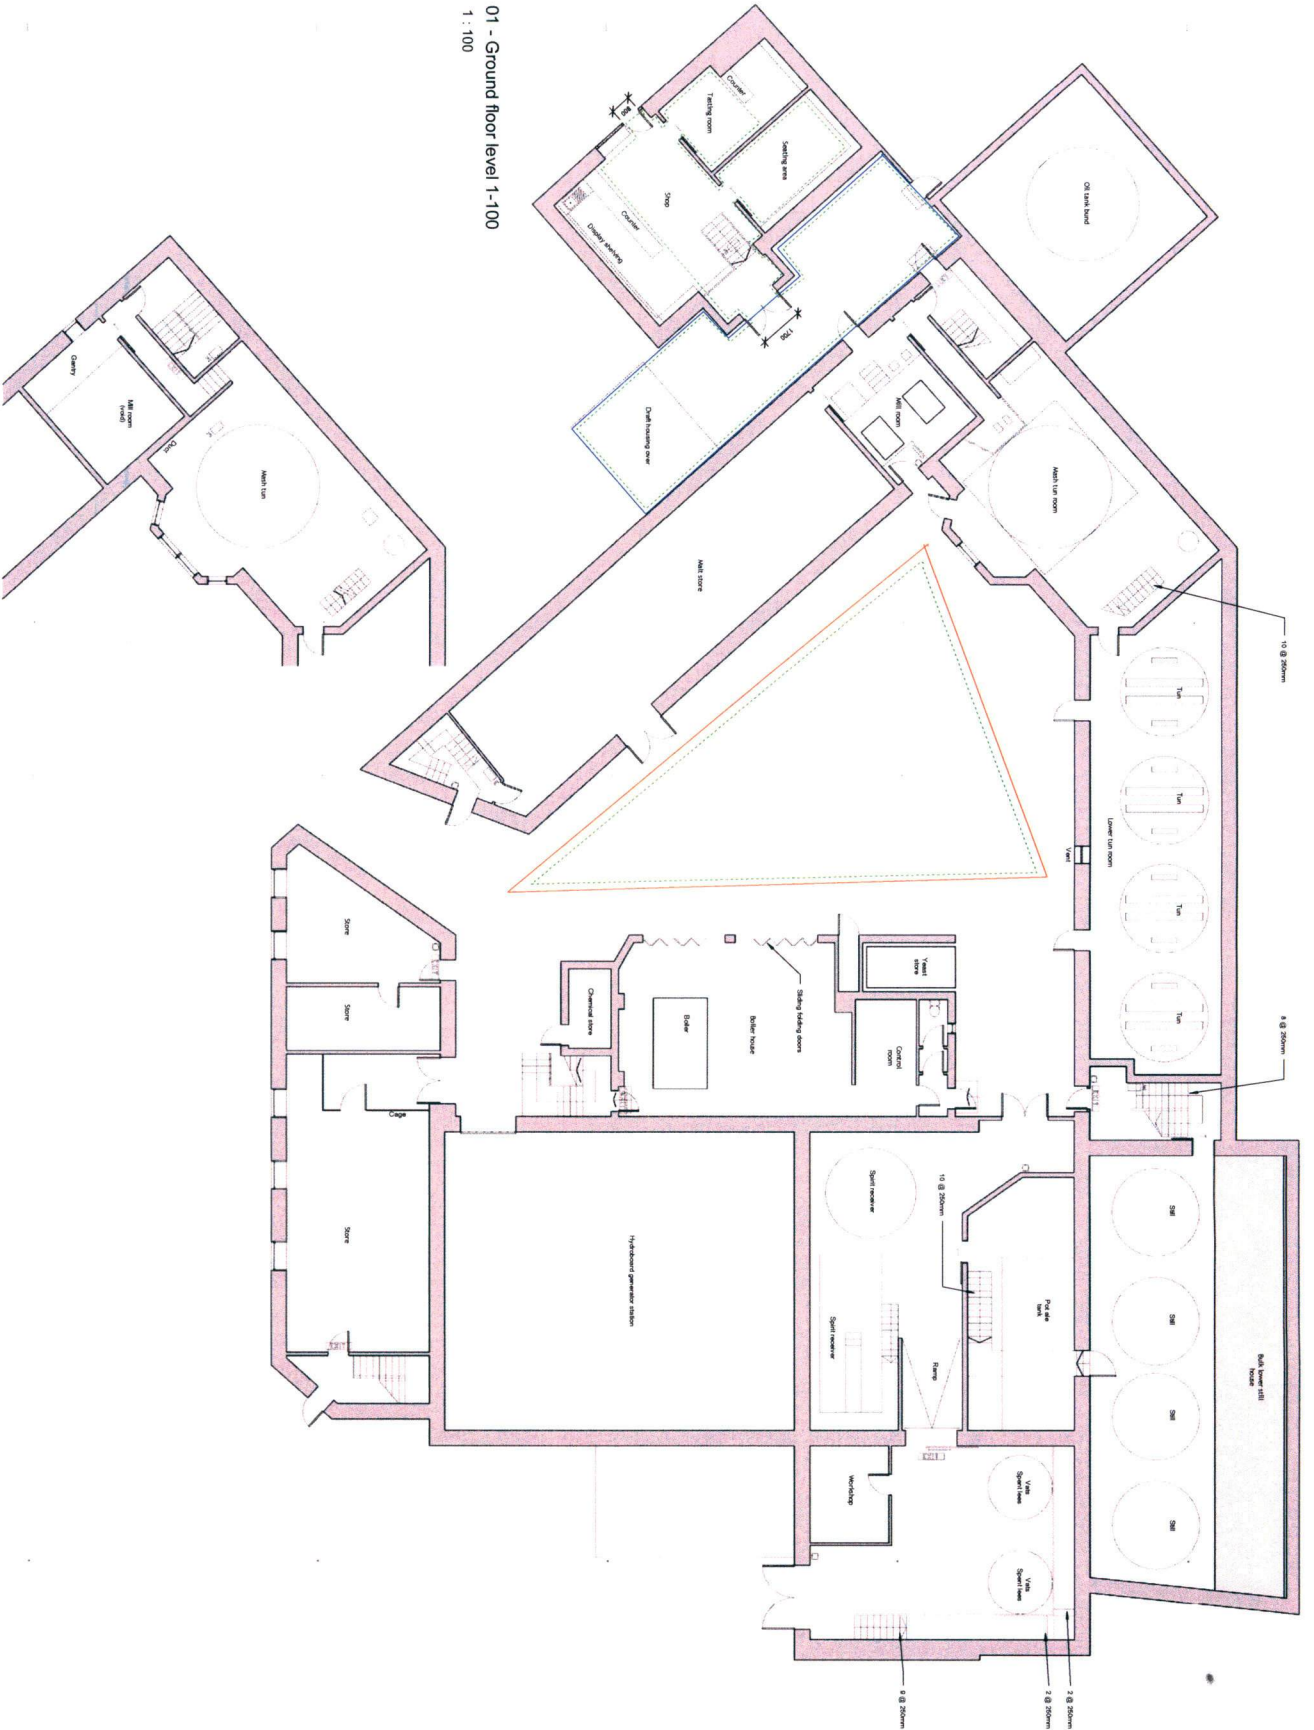

01 - Ground floor level 1-100
1 : 100

02 - Mash house mezzanine level 1-100
1 : 100

James Barr

228 West George Street, Glasgow, G2 2JA
Tel: 0141 302 0001
www.jamesbarr.co.uk

20th Flr
Burn Stewart
Leding Distillery,
Tobermory,
Isle of Mull


Drawing title
Levels 1 and 2 showing
emergency lighting

Sheet	Sheet size	Client No.	Client
01	A1	100000000	James Barr
02	A1	100000000	James Barr
03	A1	100000000	James Barr
100	A1	100000000	James Barr


Drawing Number: B48293 (EX) 02 Revision:

Copyright of James Barr © All Rights Reserved.
Do not scale from this drawing. If in any doubt, ask.

- Electrical legend**
- Fryer/oven
 - Microwave oven
 - Microwave emergency stop
 - Smoke detector
 - Children & Young Persons Access

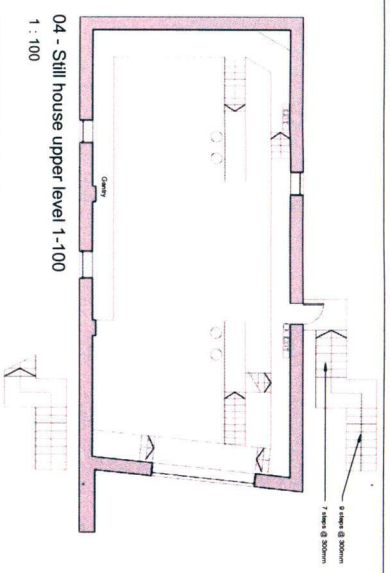

04 - Still house upper level 1-100
1 : 100

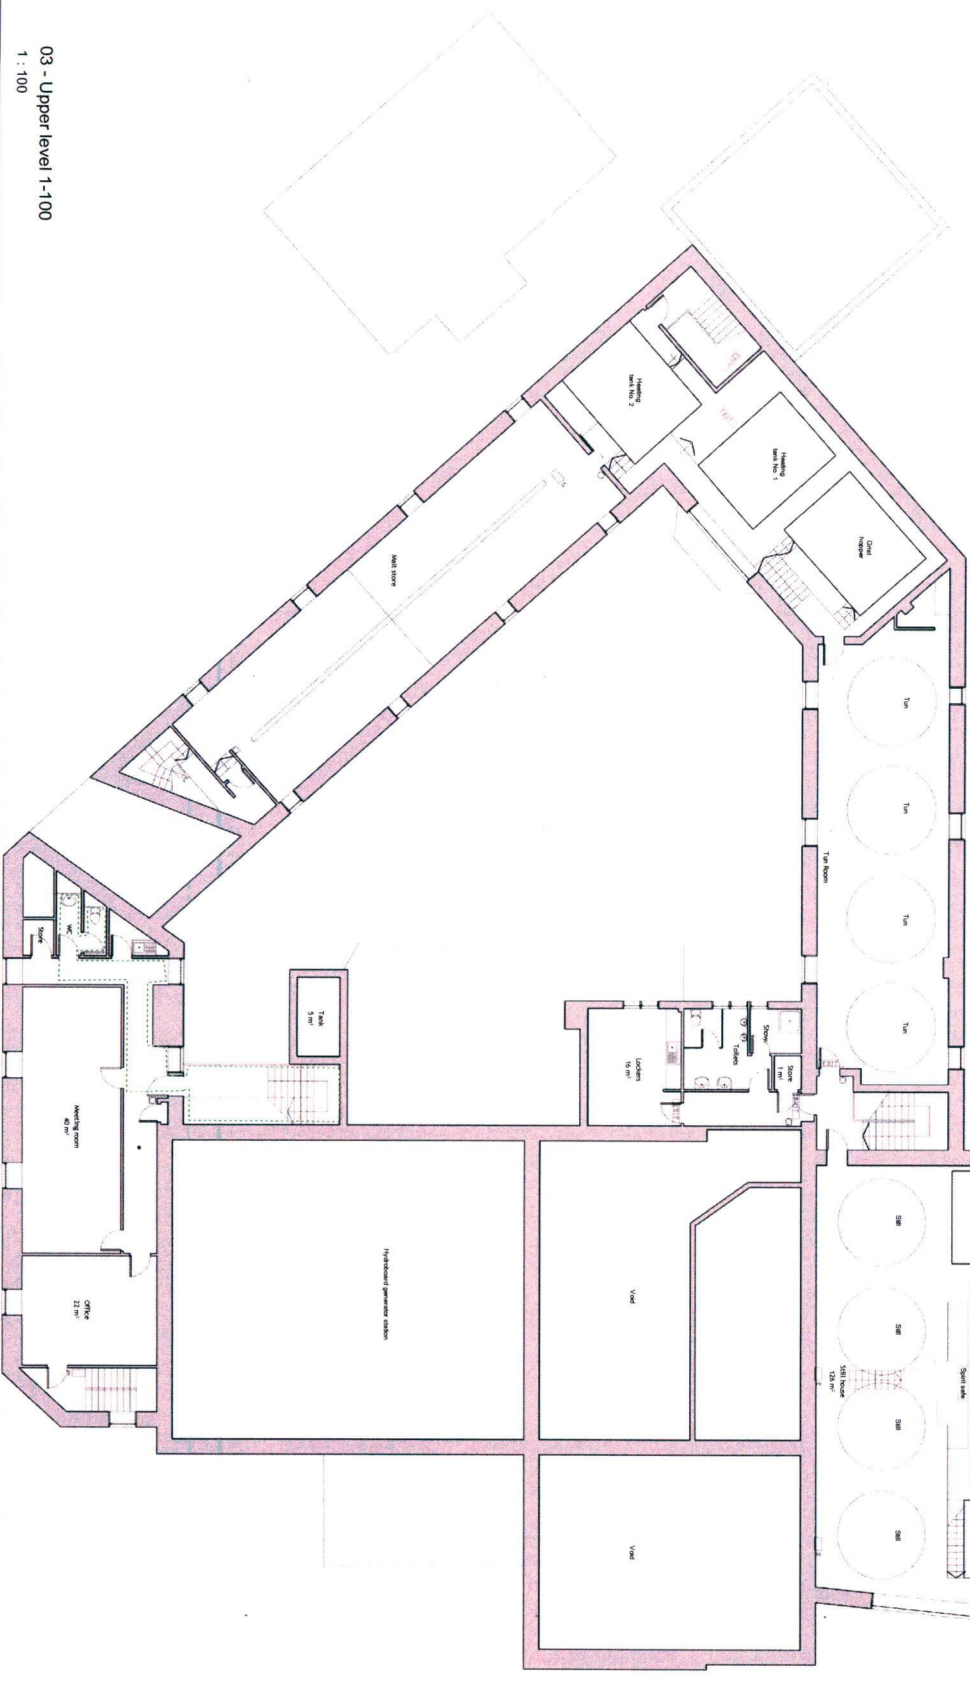

03 - Upper level 1-100
1 : 100

James Barr

228 West George Street, Glasgow, G2 2JL
Tel: 0141 300 0001
www.jamesbarr.co.uk

206 Title
Burn Stewart
Leding Distillery,
Tobemory,
Isle of Mull

Level 3 and 4 showing
emergency lighting

Client	Drawn by	Checked by	Date
James Barr	NI	SD	24/09/24
Drawn by	NI	SD	24/09/24
Checked by	NI	SD	24/09/24

Drawing Number: B48293 (EX) 03