


GROUND FLOOR PLAN AS EXISTING  
Scale 1:50

outside  
3.6m  
≈ 6.34m

Legend

- |  |  |  |                                |
|--|--|--|--------------------------------|
|  | - 1500mm Long, Florescent Light Fittings |  | - Ceiling Mounted Luminares    |
|  | - Radiator                               |  | - Hand Dryer                   |
|  | - Spur Socket                            |  | - Passive Infra Red Detector   |
|  | - Double Socket                          |  | - Fire Alarm Break Glass Point |
|  | - 1 Way Light Switch                     |  | - Network Point                |
|  | - Distribution Board                     |  | - Carbon Dioxide Extinguisher  |
|  | - Roof Mounted Suspended Luminares       |  | - Water Extinguisher 9Litre    |
|  | - Smoke Detector                         |  | - Fan                          |
|  | - Ceiling Mounted Luminares              |  | - Ship to Shore                |

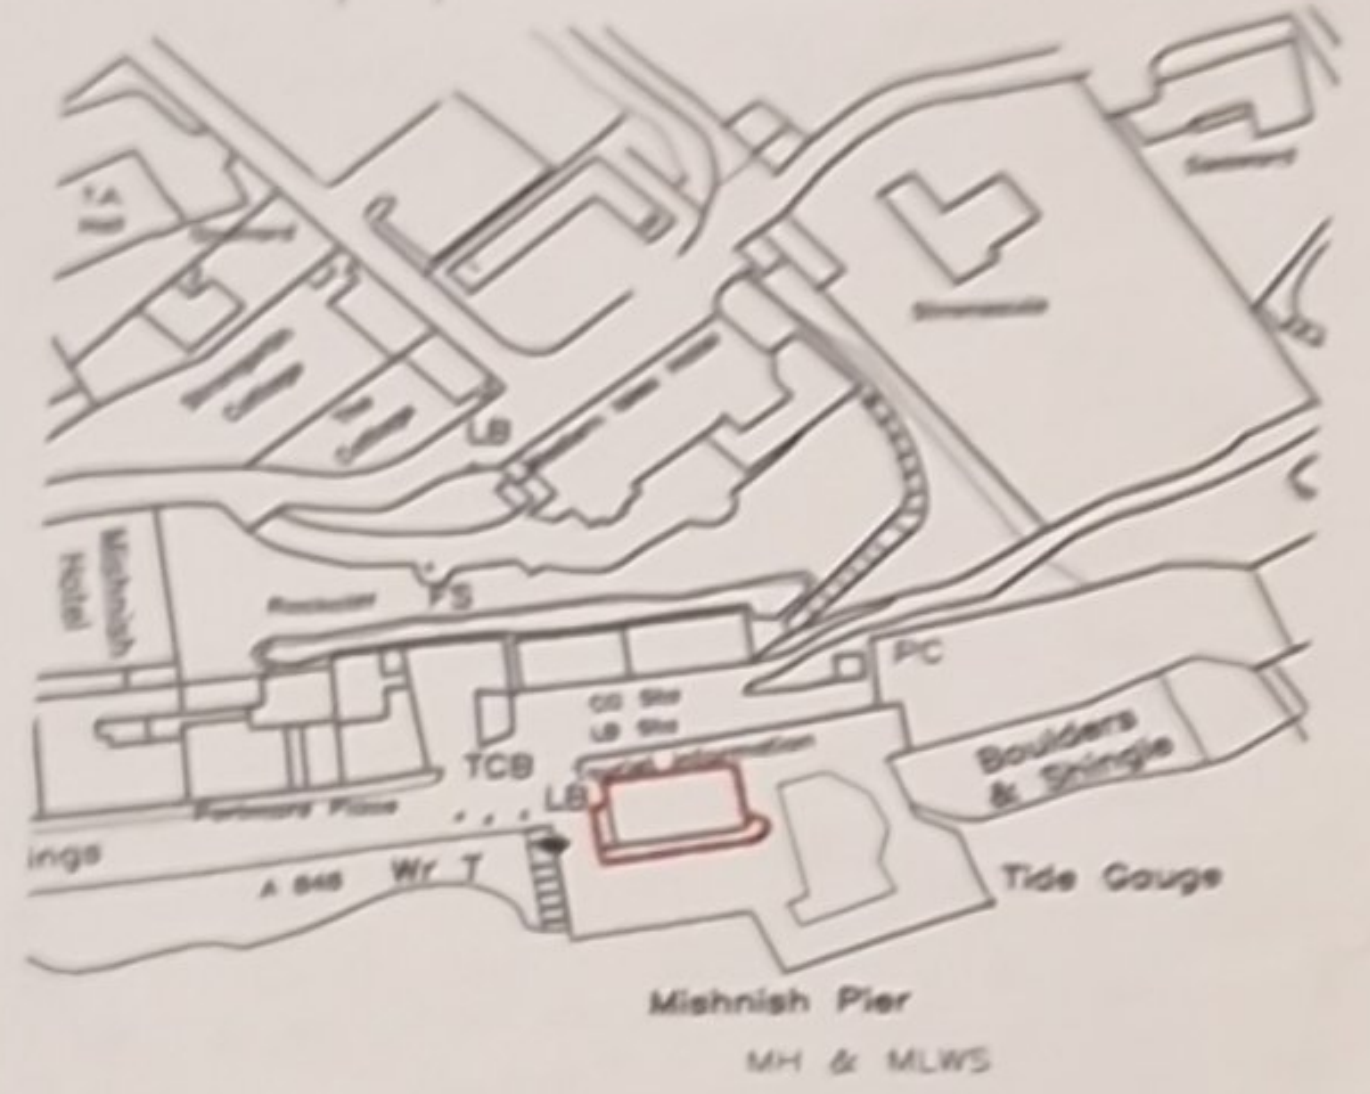

LOCATION PLAN  
Scale 1:1250

Crown Copyright 2012. All rights reserved.  
Licence number 100020449

Revision: A Date: 19/04/2012 Description: updated drawing to do built



CLIENT CMAL	
PROJECT TOBERMORY FERRY TERMINAL, TOBERMORY, ISE OF MURY, PA75 6NU	
Dwg. TITLE GROUND FLOOR AS EXISTING & LOCATION PLANS	
DWG. No. GB 8688/25a	SCALE A2 @ As Shown
DRAWN BY APD	CHECKED BY DATE 19.04.2012