

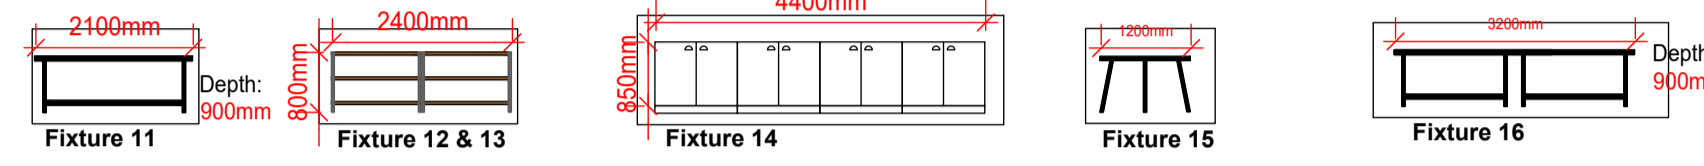
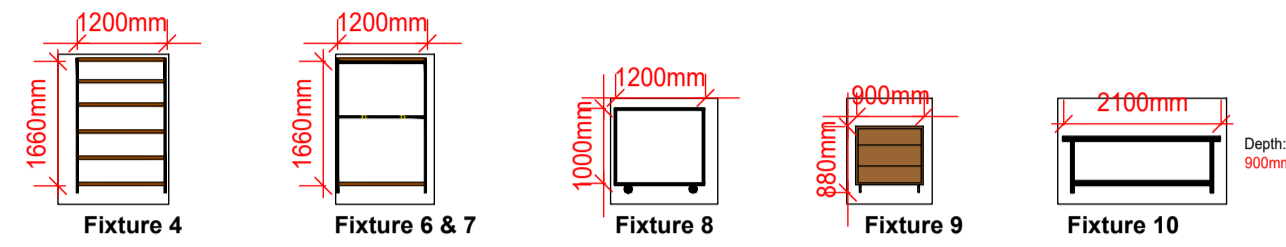


Caol Ila Distillery
Third Floor Plan - Brand Home
LICENSING

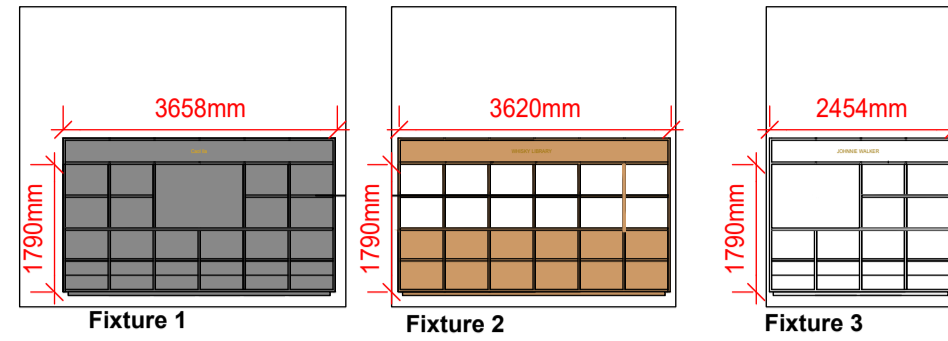

Overall Site Plan
Scale 1:1250@A1 / 1:2500@A3

Scale: 0 25 50 75 100m

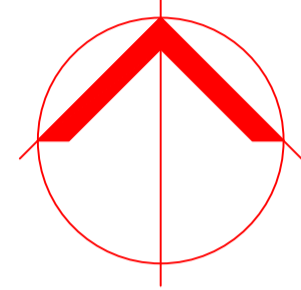

Fixture	Dimension (m)	Storage capacity (m ²)
Fixture 1	1.79m x 3.66m	6.55 m ²
Fixture 2	1.79m x 3.62m	6.48 m ²
Fixture 3	1.79m x 2.45m	4.39 m ²
Fixture 4	1.66m x 1.2m	1.99 m ²
Fixture 6	1.66m x 1.2m	1.99 m ²
Fixture 7	1.66m x 1.2m	1.99 m ²
Fixture 12	0.8m x 2.4 m	1.68 m ²
Fixture 13	0.8m x 2.4m	1.68 m ²
		26.75 m²

Fixture	Dimension (m)	Storage capacity (m ³)
Fixture 8	1.0m x 1.2m x 0.5m	0.60 m ³
Fixture 9	0.9m x 0.88 x 0.6m	0.48 m ³
Fixture 10	0.9m x 2.1m x 0.5m	0.94 m ³
Fixture 11	0.9m x 2.1m x 0.5m	0.94 m ³
Fixture 14	0.85m x 4.4m x 0.5m	1.87 m ³
Fixture 15	1.2m x 1.2m x 1.5m	2.16 m ³
Fixture 16	0.9m x 3.2m x 1.5m	4.32 m ³
Bottle your own	1.65 m x 1.6m x 1m	2.64 m ³
Bench Display	1.83m x 0.3m x 0.5m	0.28 m ³
Retail Chests (8)	0.68m x 0.5m x 0.5m	1.36 m ³
		15.59 m³

NOTE
Do not scale from this drawing - all dimensions should be checked on site by the contractor prior to construction and discrepancies notified to the architect immediately.

This drawing should be read in conjunction with the architect's drawings, specification and schedules, and those provided by the other consultants. This drawing is issued for the purpose stated only and does not supersede the requirement for other statutory consents.


Display Furniture
Scale 1:100@A1 / 1:200@A3

Scale: 0 1 2 3 4 5m



Third Floor Plan
Scale 1:100@A1 / 1:200@A3

Scale: 0 1 2 3 4 5m

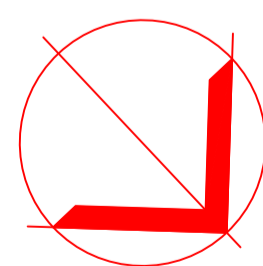

Notes

Licensing Key

- Extent of Licence Area
- External License Area
- Areas NOT accessible by children and young persons
- Future additional event space
- Fire alarm
- Fire exit signage
- Alcohol
- Break glass fire alarm point
- Smoke detector
- Point of sale
- CO2 Fire extinguisher
- FOAM Fire extinguisher
- WATER Fire extinguisher

Revisions	Date	Drn.
First issue	29.04.2022	KMC
A Drawing updated	06.05.2022	KMC
B Drawing updated	09.05.2022	KMC
C Drawing updated	10.05.2022	KMC
D Drawing updated	16.05.2022	KMC
E Areas amended to reflect volume on selected displays.	02.10.2023	BKS

DIAGEO Ltd

LICENSING DRAWING

BLYTH&BLYTH
Cornerstone, 60 South Gyle Crescent
Edinburgh EH12 9EB
Email: edinburgh@blythandblyth.co.uk
www.blythandblyth.co.uk Telephone: 0131 474 2700

CAOL ILA DISTILLERY
VISITORS CENTRE

LICENSING Third Floor Plan - Brand Home			
Drawn: KMC	Ck'd: BS	Scale: AS SHOWN@A1	
Date: Apr'22	Date:	DO NOT SCALE	
Drawing No. AZ70873:00:LS005		Revision E	