


0 5 10 20 30 40 50 60 70 80 90 100 millimetres

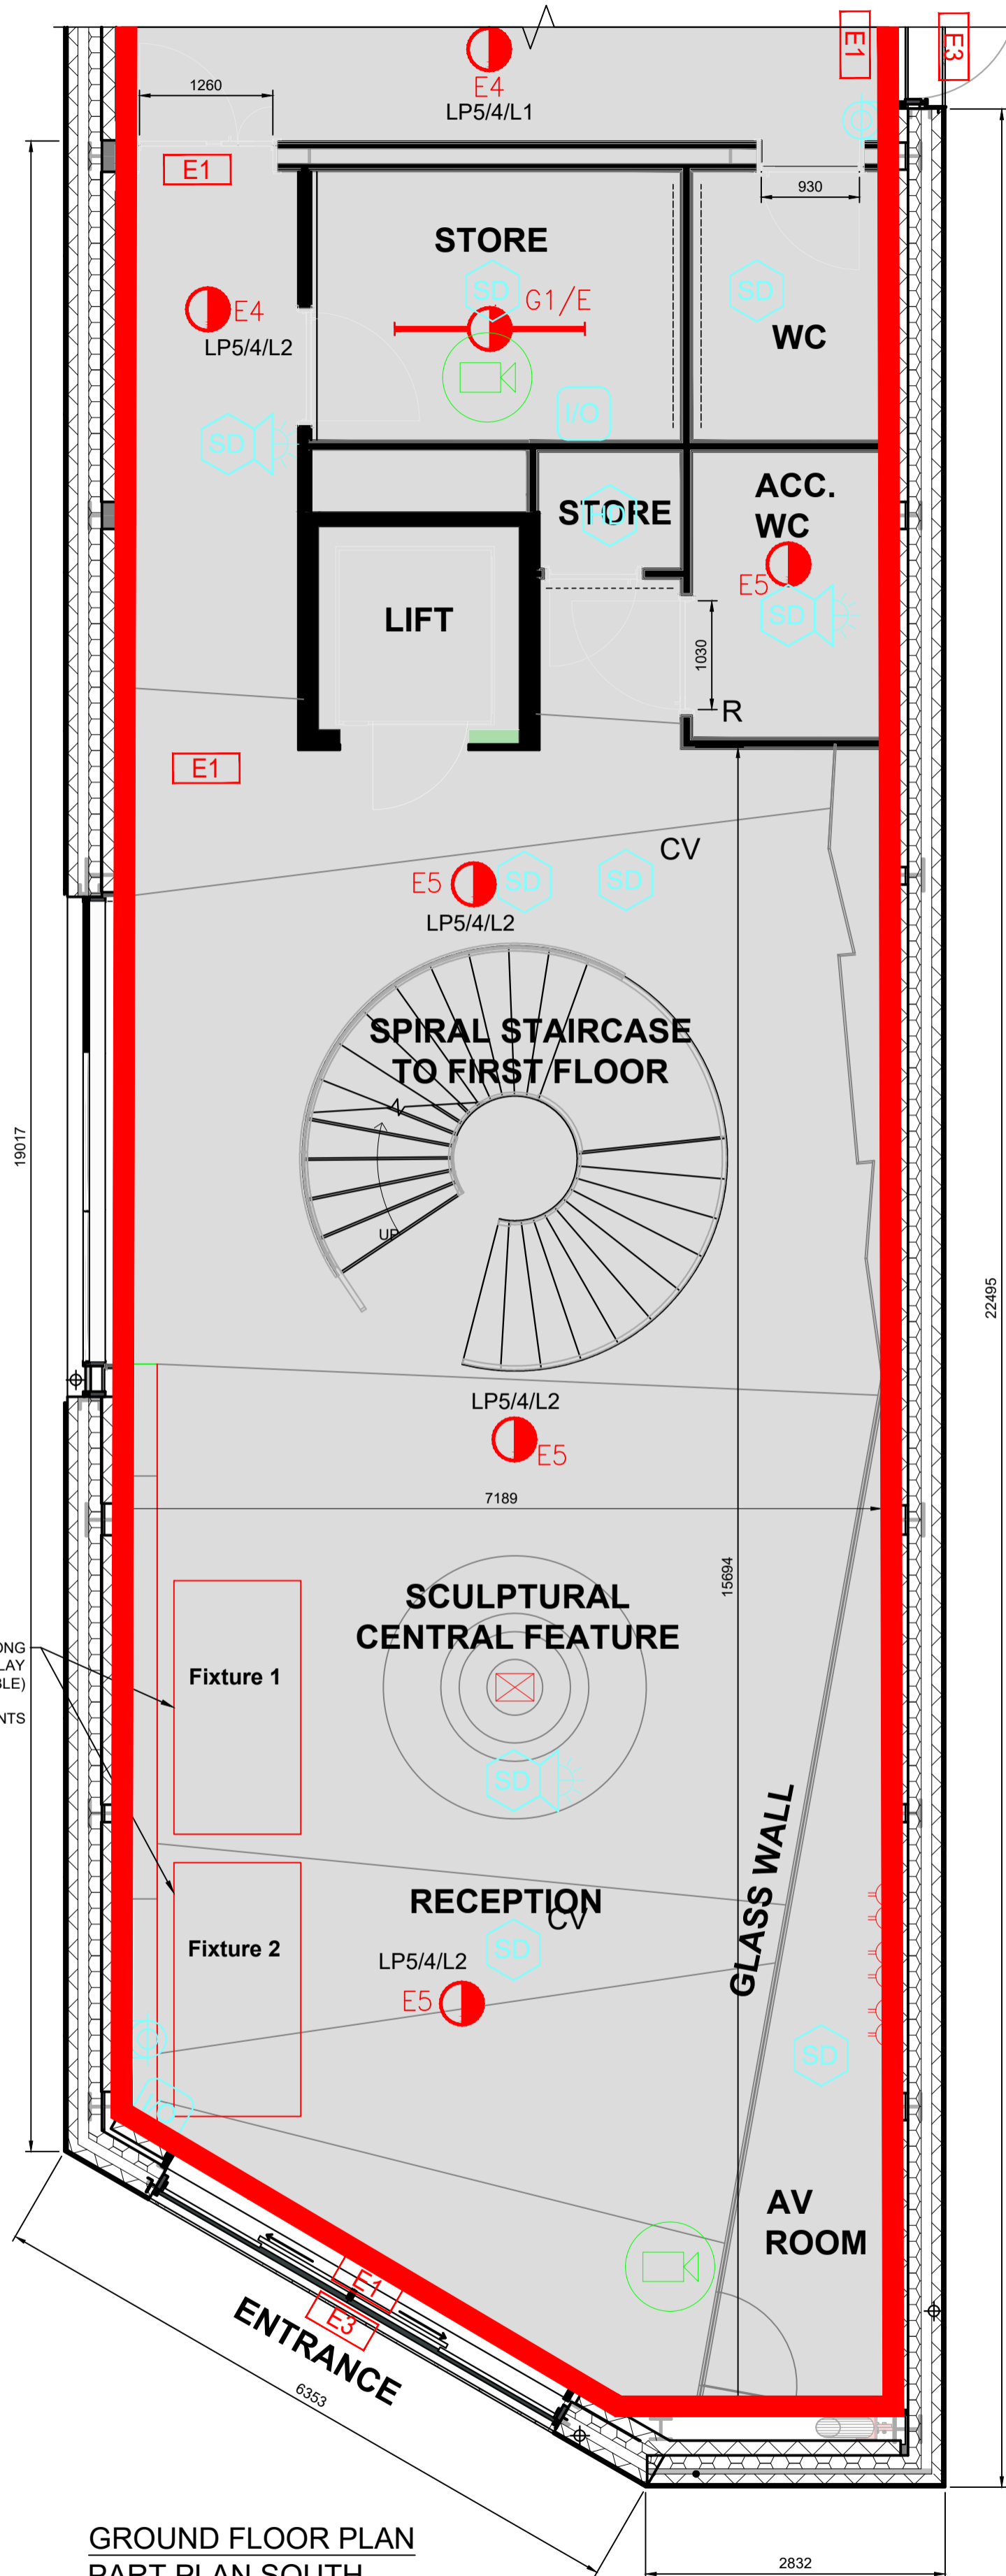

GROUND FLOOR PLAN
PART PLAN SOUTH
1:50



GROUND FLOOR PLAN
PART PLAN NORTH
1:50

Legend:

- Red line boundary indicates extent of Licence Application
- Areas of NO ACCESS to children and Young persons

Occupant Capacity - Visitor Center - Ground Floor

Room	Area (m ²)	OLF	Occupant Capacity	No. of Escapes
Reception	78	1	78	2
Exhibition	29	1	29	2
Kitchen	28	6	5	2
TOTAL			112 PERSONS	

Fixture	Usage	Storage Capacity (m ³)	QTY	Total (m ³)
1	Alcohol	2.4x1.2x0.55H	1	1.58
2	Alcohol	2.4x1.2x0.55H	1	1.58
TOTAL				3.16

FIRE ALARM LEGEND

- MANUAL CALL POINT
- SMOKE DETECTOR
- HEAT DETECTOR
- DETECTOR SOUNDER
- DETECTOR SOUNDER WITH FLASHING BEACON
- DISABLED ALARM RESET UNIT
- DISABLED ALARM BEACON
- DISABLED ALARM PULL CORD
- CCTV CAMERA
- FIRE ALARM INTERFACE UNIT
- EMERGENCY LIGHTING
- EMERGENCY EXIT SIGNAGE

Revisions	Date	Drn.

LICENSING APPLICATION

DIAGEO Ltd

PORT ELLEN MALTINGS
NEW DISTILLERY

VISITORS CENTRE
LICENCE APPLICATION
SHEET 2 OF 4

Drawn: AS	Ck'd:	Scale: 1:50 @ A1
Date: Nov 2023	Date:	DO NOT SCALE

BLYTH & BLYTH
Cornerstone, 60 South Gyle Crescent
Edinburgh EH12 9EB
Email: edinburgh@blythandblyth.co.uk
www.blythandblyth.co.uk Telephone: 0131 474 2700

Drawing No. AZ70764:34:002	Revision
----------------------------	----------