




FIRST FLOOR PLAN
PART PLAN SOUTH
1:50

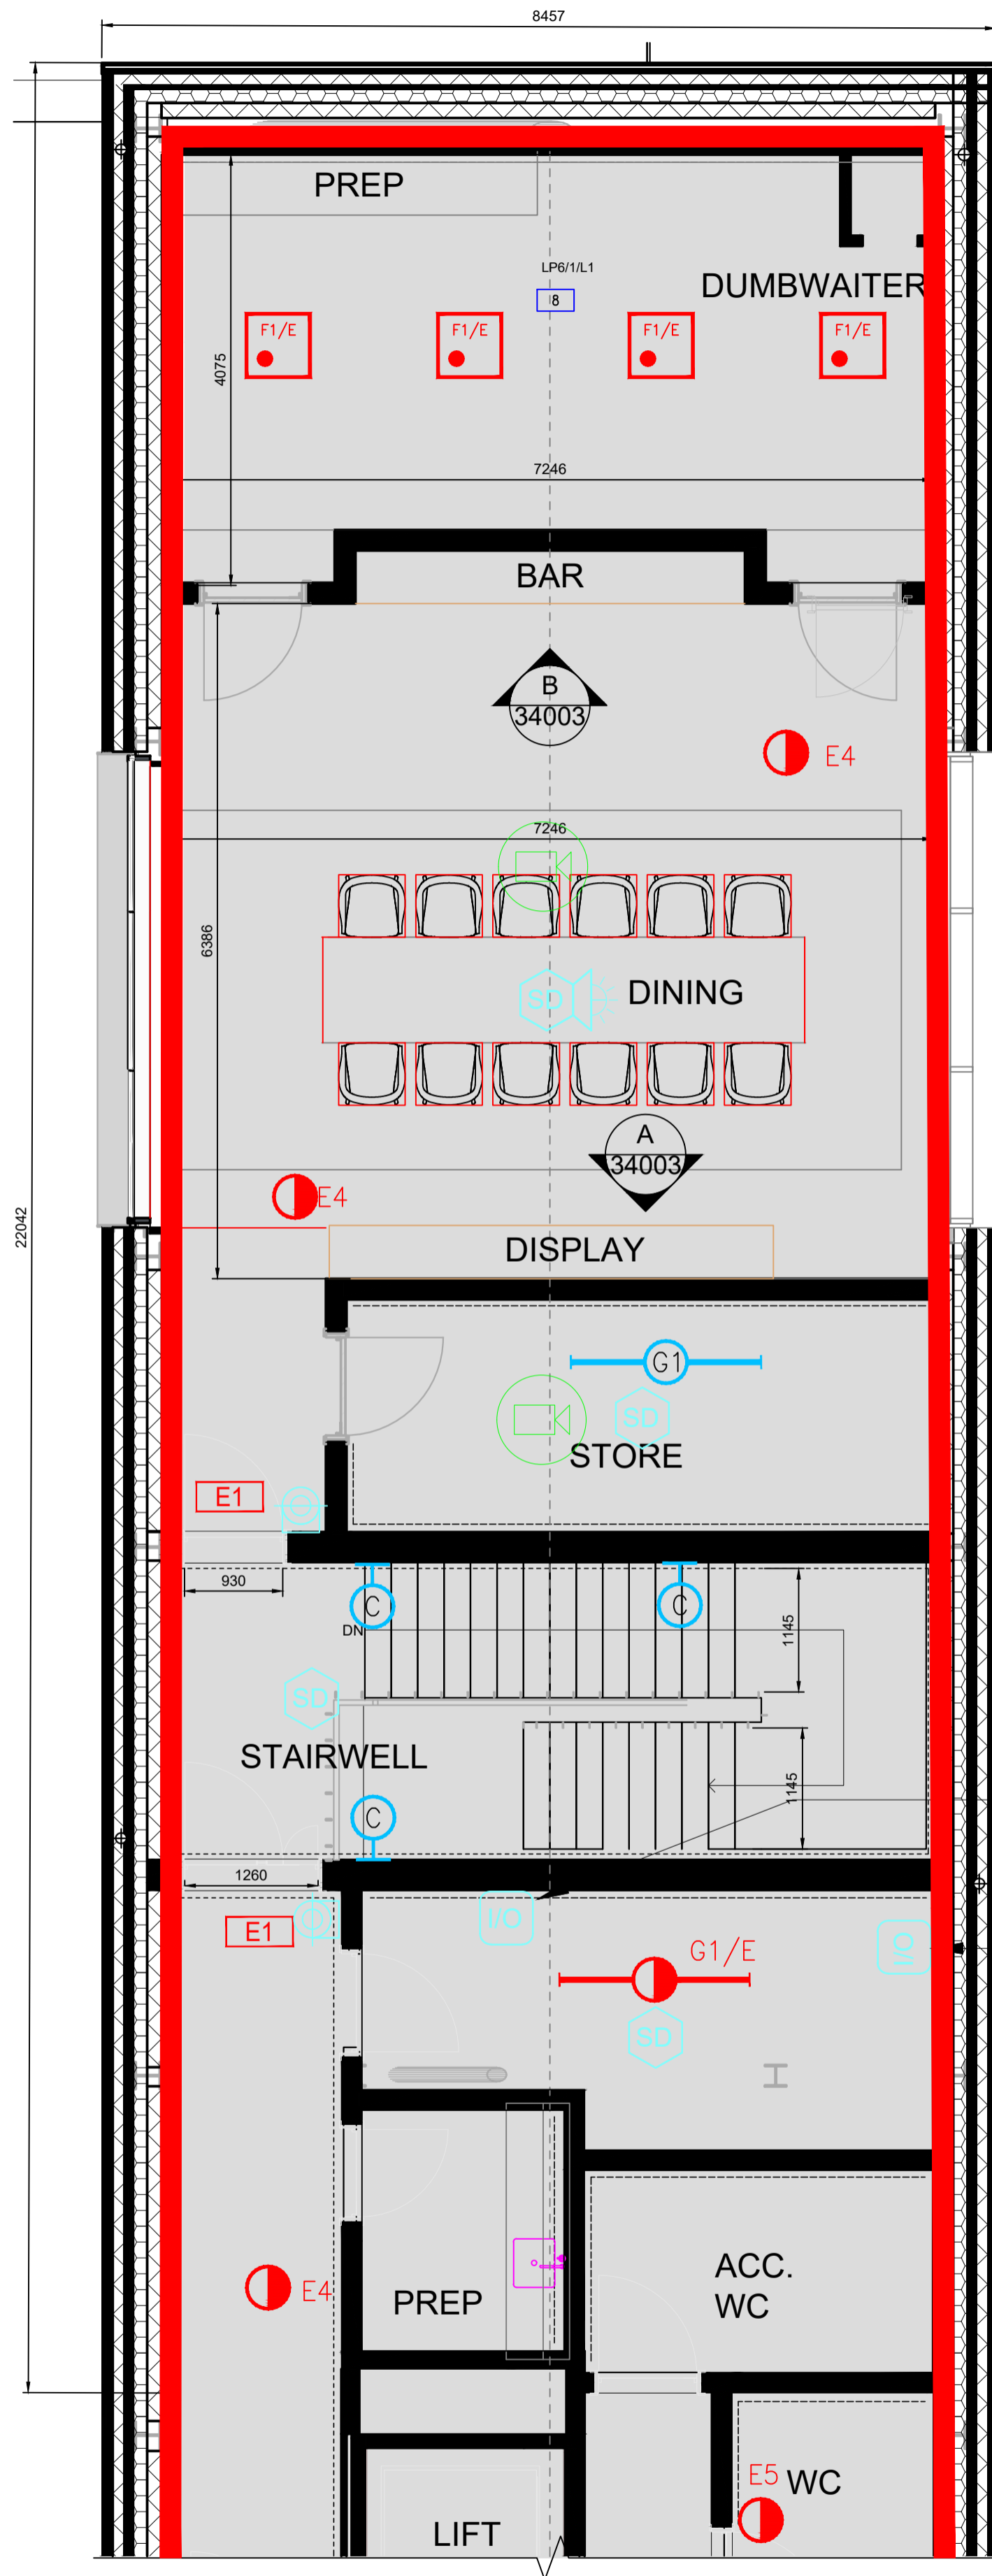


FIRST FLOOR PLAN
PART PLAN NORTH
1:50

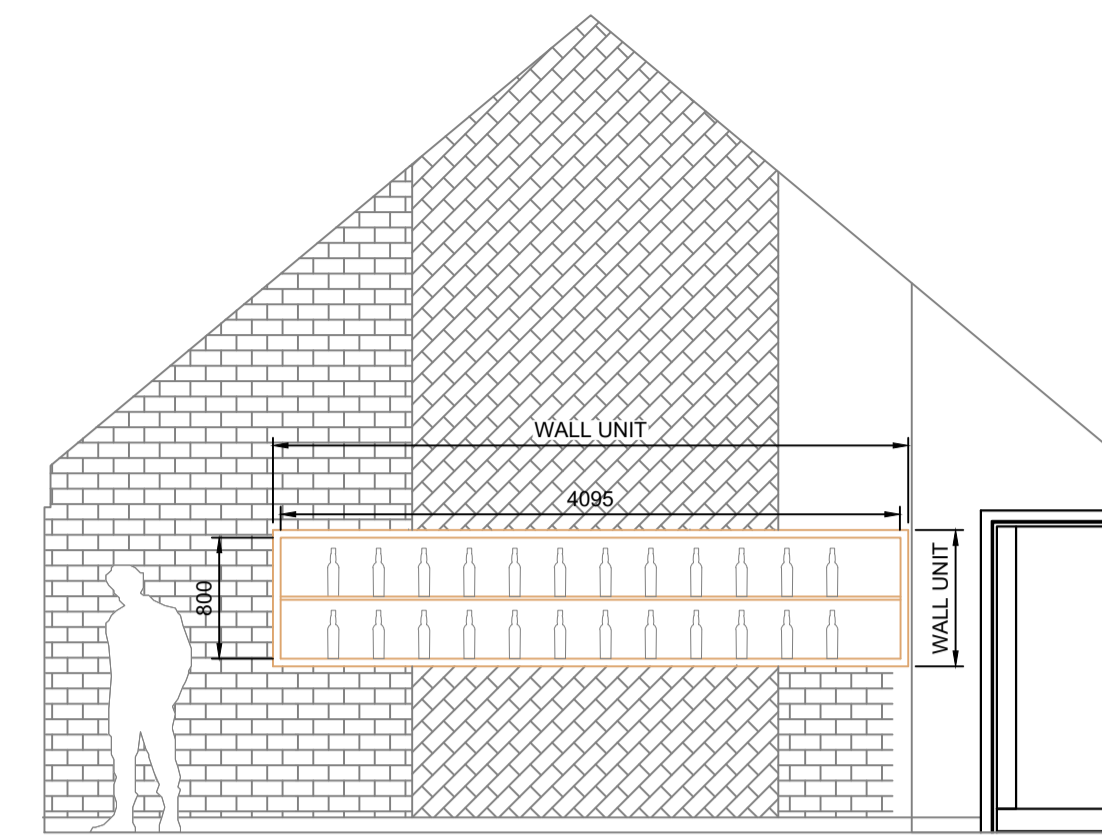

ELEVATION A (WALL CABINET)
1:50

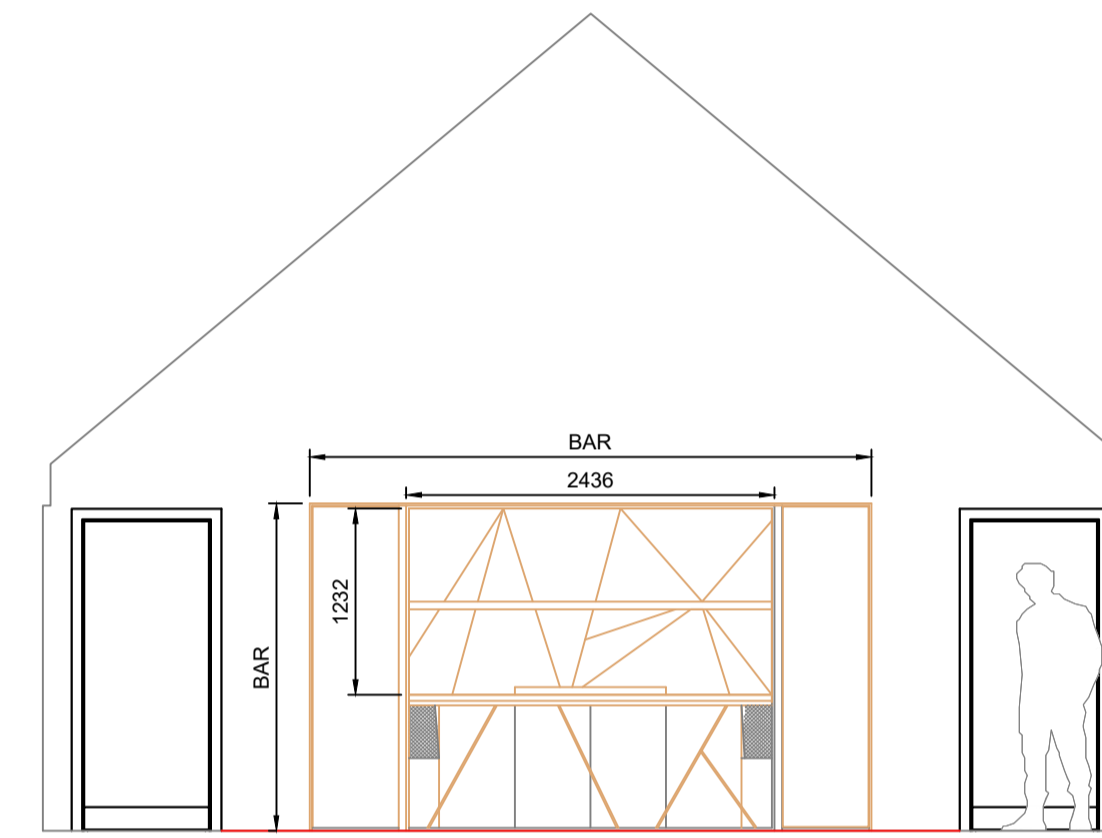

ELEVATION B (BAR)
1:50

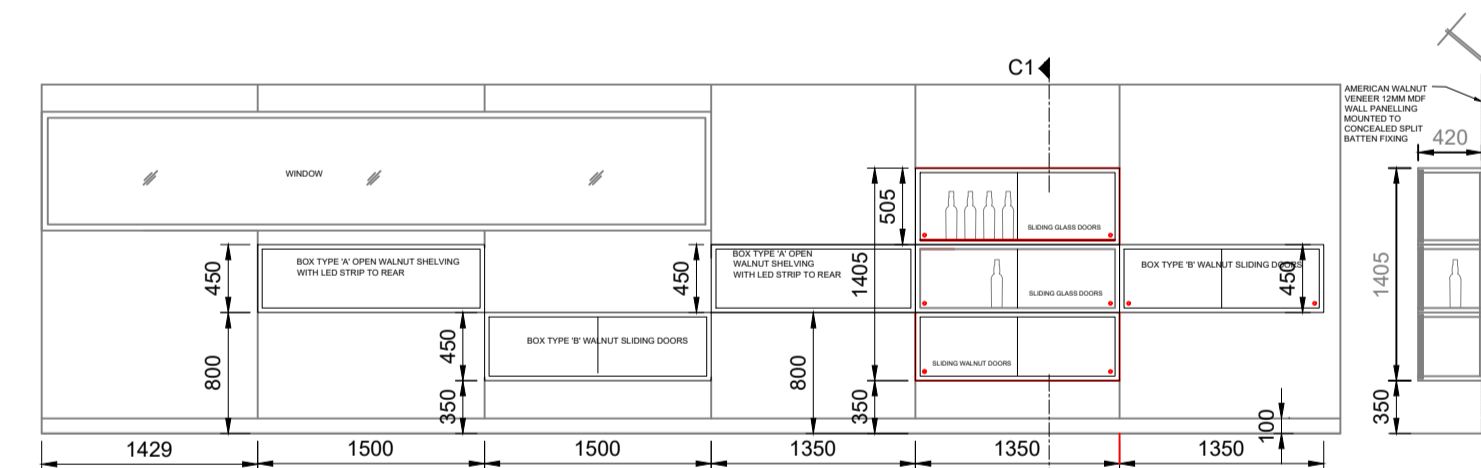

SECTION
C1-C1

ELEVATION C (WALL CABINETS)
1:50

Occupant Capacity - First Floor Plan

Room	Area (m ²)	OLF	Occupant Capacity	No. of Escapes
Lounge & Balcony	75	1	75	2
Dinning/Bar	49	-	12	1
Prep	28	6	5	1
TOTAL			92 PERSONS	

Elevation	Usage	Storage Capacity (m ²)	QTY	Total (m ²)
A	Alcohol	4.1x0.8	1	3.28
B	Alcohol	2.4x1.2	1	2.88
C	Alcohol	1.5x0.45 typ	7	4.72
TOTAL				10.9

Legend:

- Red line boundary indicates extent of Licence Application
- Areas of NO ACCESS to children and Young persons

FIRE ALARM LEGEND

- MANUAL CALL POINT
- SMOKE DETECTOR
- HEAT DETECTOR
- DETECTOR SOUNDER
- DETECTOR SOUNDER WITH FLASHING BEACON
- DISABLED ALARM RESET UNIT
- DISABLED ALARM BEACON
- DISABLED ALARM PULL CORD
- CCTV CAMERA
- FIRE ALARM INTERFACE UNIT
- E4 - EMERGENCY LIGHTING
- E1 - EMERGENCY EXIT SIGNAGE

Revisions	Date	Drn.

LICENSING APPLICATION

DIAGEO Ltd

**PORT ELLEN MALTINGS
NEW DISTILLERY**

**VISITORS CENTRE
LICENCE APPLICATION
SHEET 3 OF 4**

Drawn: AS Ck'd: Scale: 1:50 @ A1
Date: Nov 2023 Date: DO NOT SCALE

BLYTH & BLYTH
Cornerstone, 60 South Gyle Crescent
Edinburgh EH12 9EB
Email: edinburgh@blythandblyth.co.uk
www.blythandblyth.co.uk Telephone: 0131 474 2700

Drawing No. AZ70764:34:003 Revision