


Occupant Capacity - Pagoda

Room	Area (m ²)	OLF	Occupant Capacity	No. of Escapes
Pagoda	44	1	44	1
TOTAL			44 PERSONS	

Elevation	Usage	Storage Capacity (m ²)	QTY	Total (m ²)
D	Alcohol	5.83	1	5.83
E	Alcohol	7.7x2.2 + 6.2x1.1	1	23.77
TOTAL				29.6

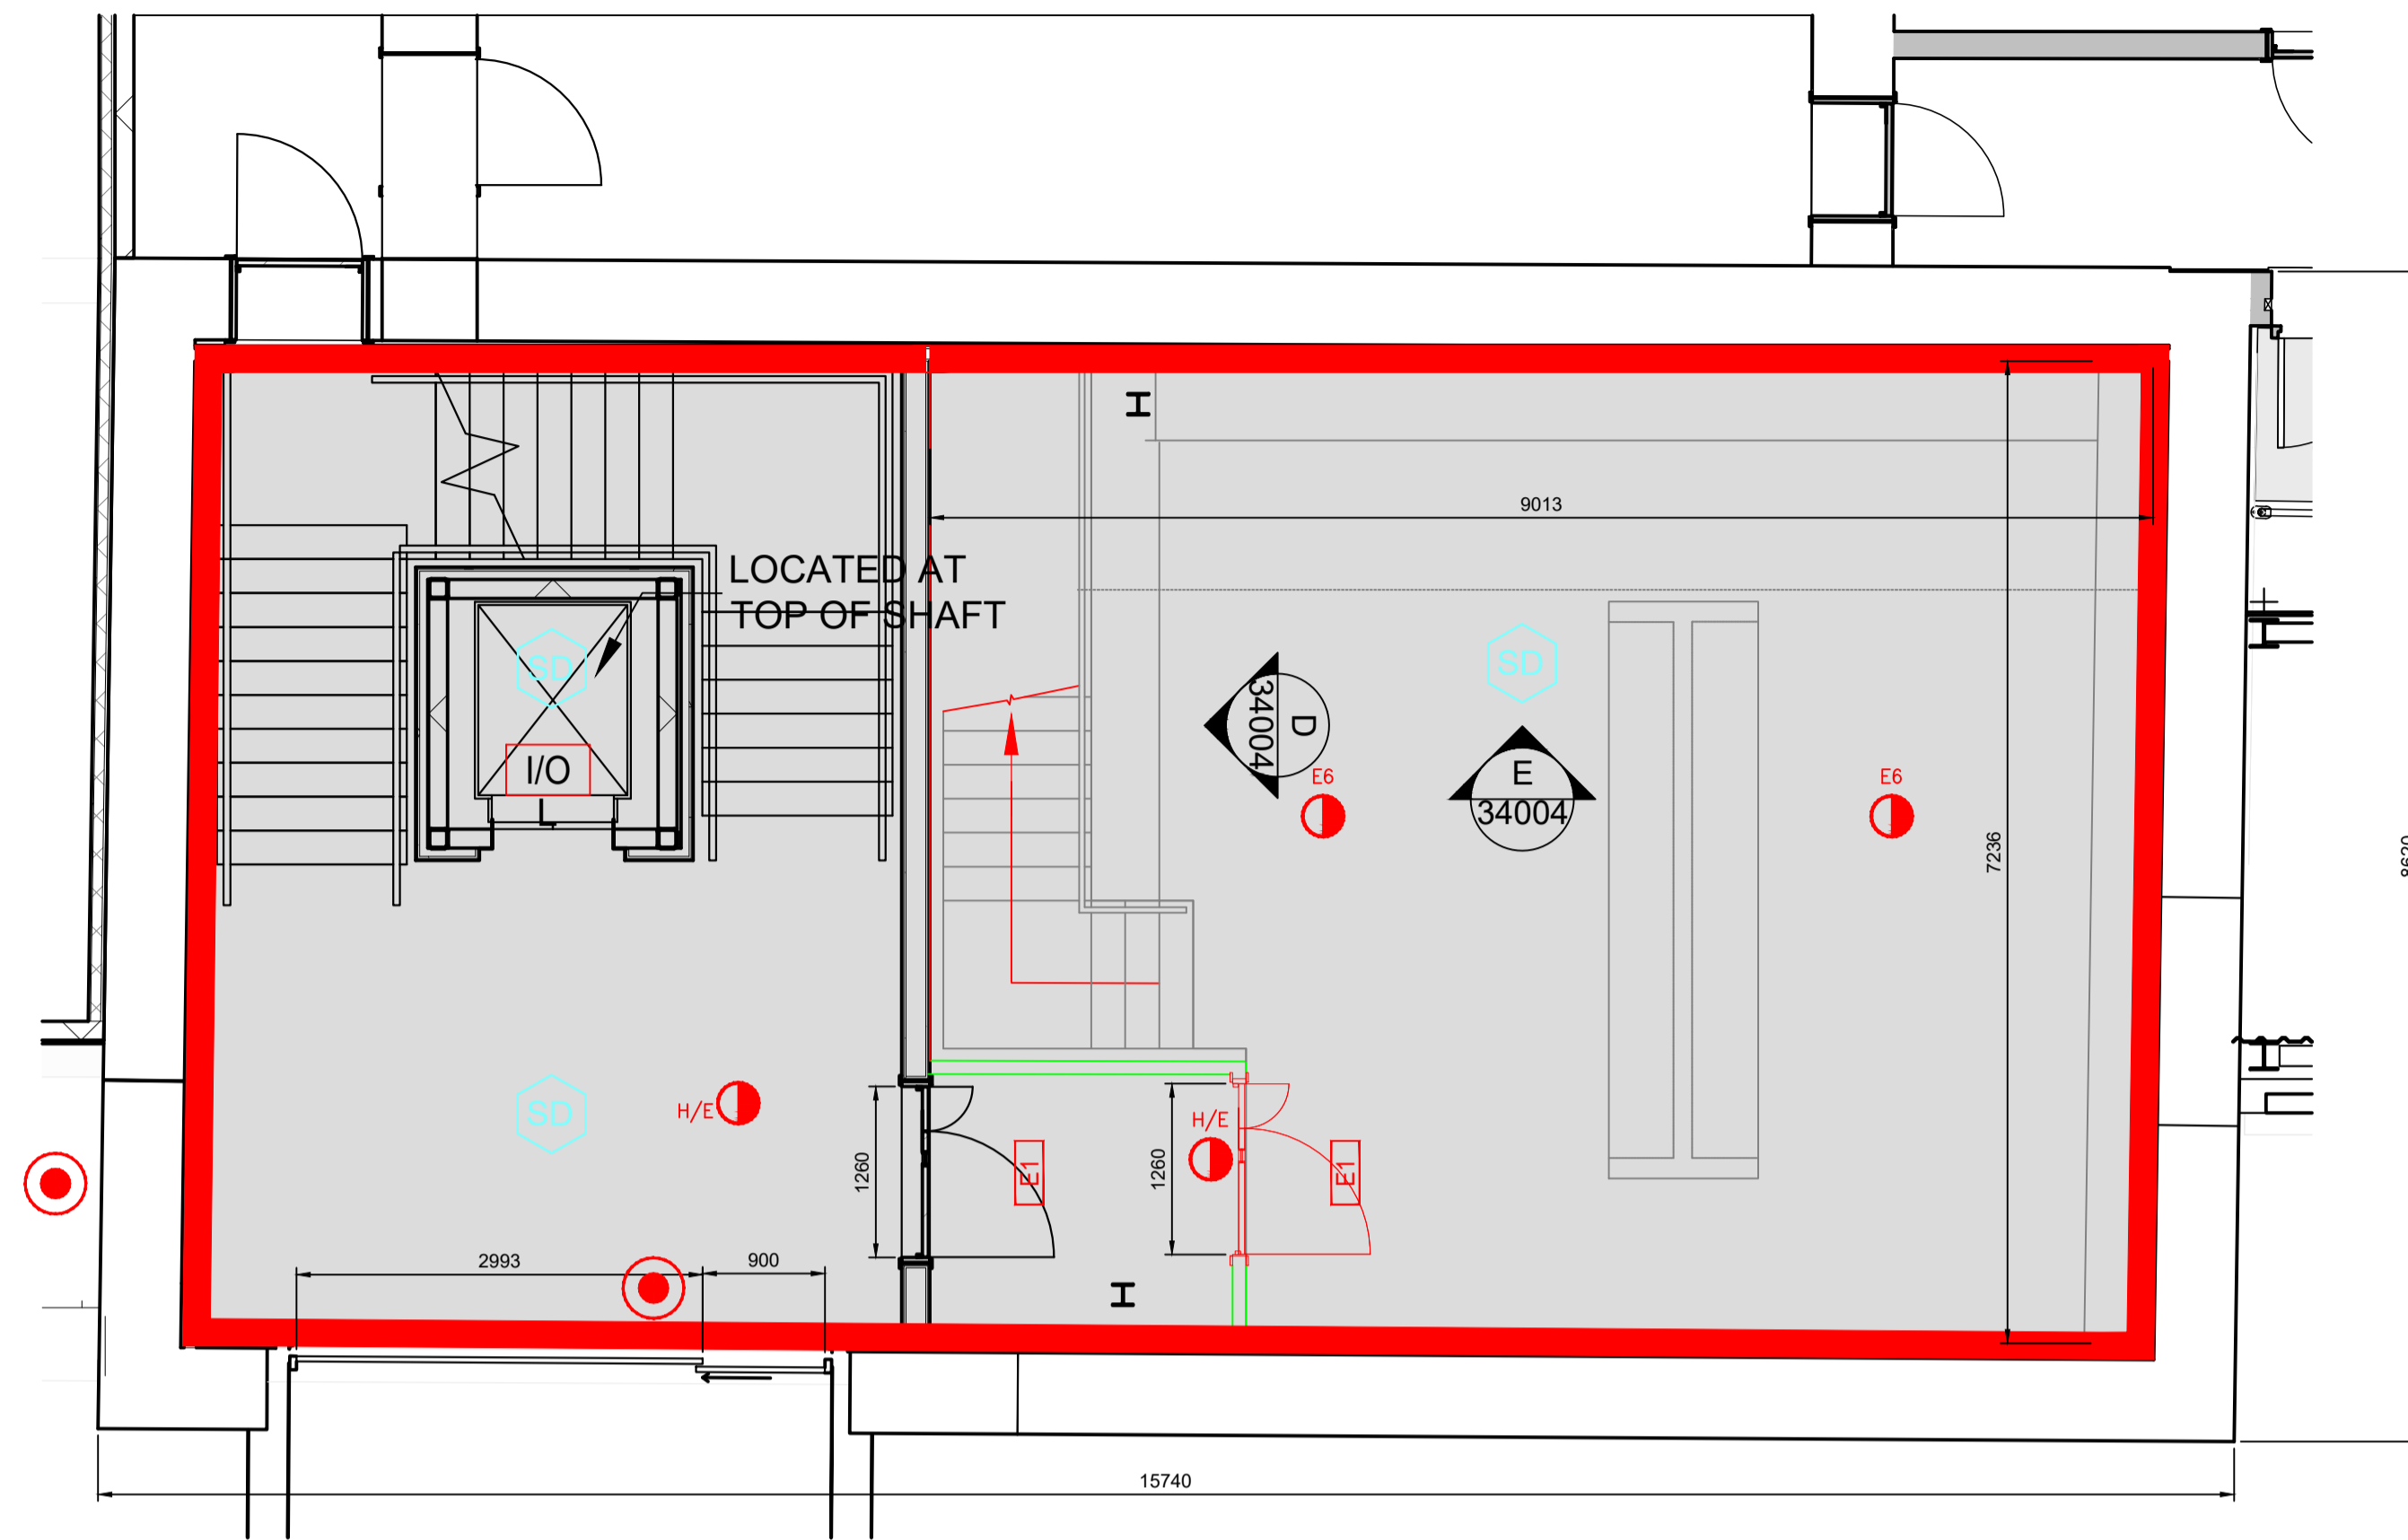

THE PAGODAS PLAN
1:50

Legend:

- Red line boundary indicates extent of Licence Application
- Areas of NO ACCESS to children and Young persons

Revisions	Date	Drn.

LICENSING APPLICATION

DIAGEO Ltd

PORT ELLEN MALTINGS
NEW DISTILLERY


VISITORS CENTRE
LICENCE APPLICATION
SHEET 4 OF 4

Drawn: AS	Ck'd:	Scale: 1:50 @ A1
Date: Nov 2023	Date:	DO NOT SCALE


BLYTH & BLYTH
Cornerstone, 60 South Gyle Crescent
Edinburgh EH12 9EB
Email: edinburgh@blythandblyth.co.uk
www.blythandblyth.co.uk Telephone: 0131 474 2700

Drawing No. AZ70764:34:004	Revision
----------------------------	----------

- FIRE ALARM LEGEND**
- MANUAL CALL POINT
 - SMOKE DETECTOR
 - HEAT DETECTOR
 - DETECTOR SOUNDER
 - DETECTOR SOUNDER WITH FLASHING BEACON
 - DISABLED ALARM RESET UNIT
 - DISABLED ALARM BEACON
 - DISABLED ALARM PULL CORD
 - CCTV CAMERA
 - FIRE ALARM INTERFACE UNIT
 - EMERGENCY LIGHTING
 - EMERGENCY EXIT SIGNAGE

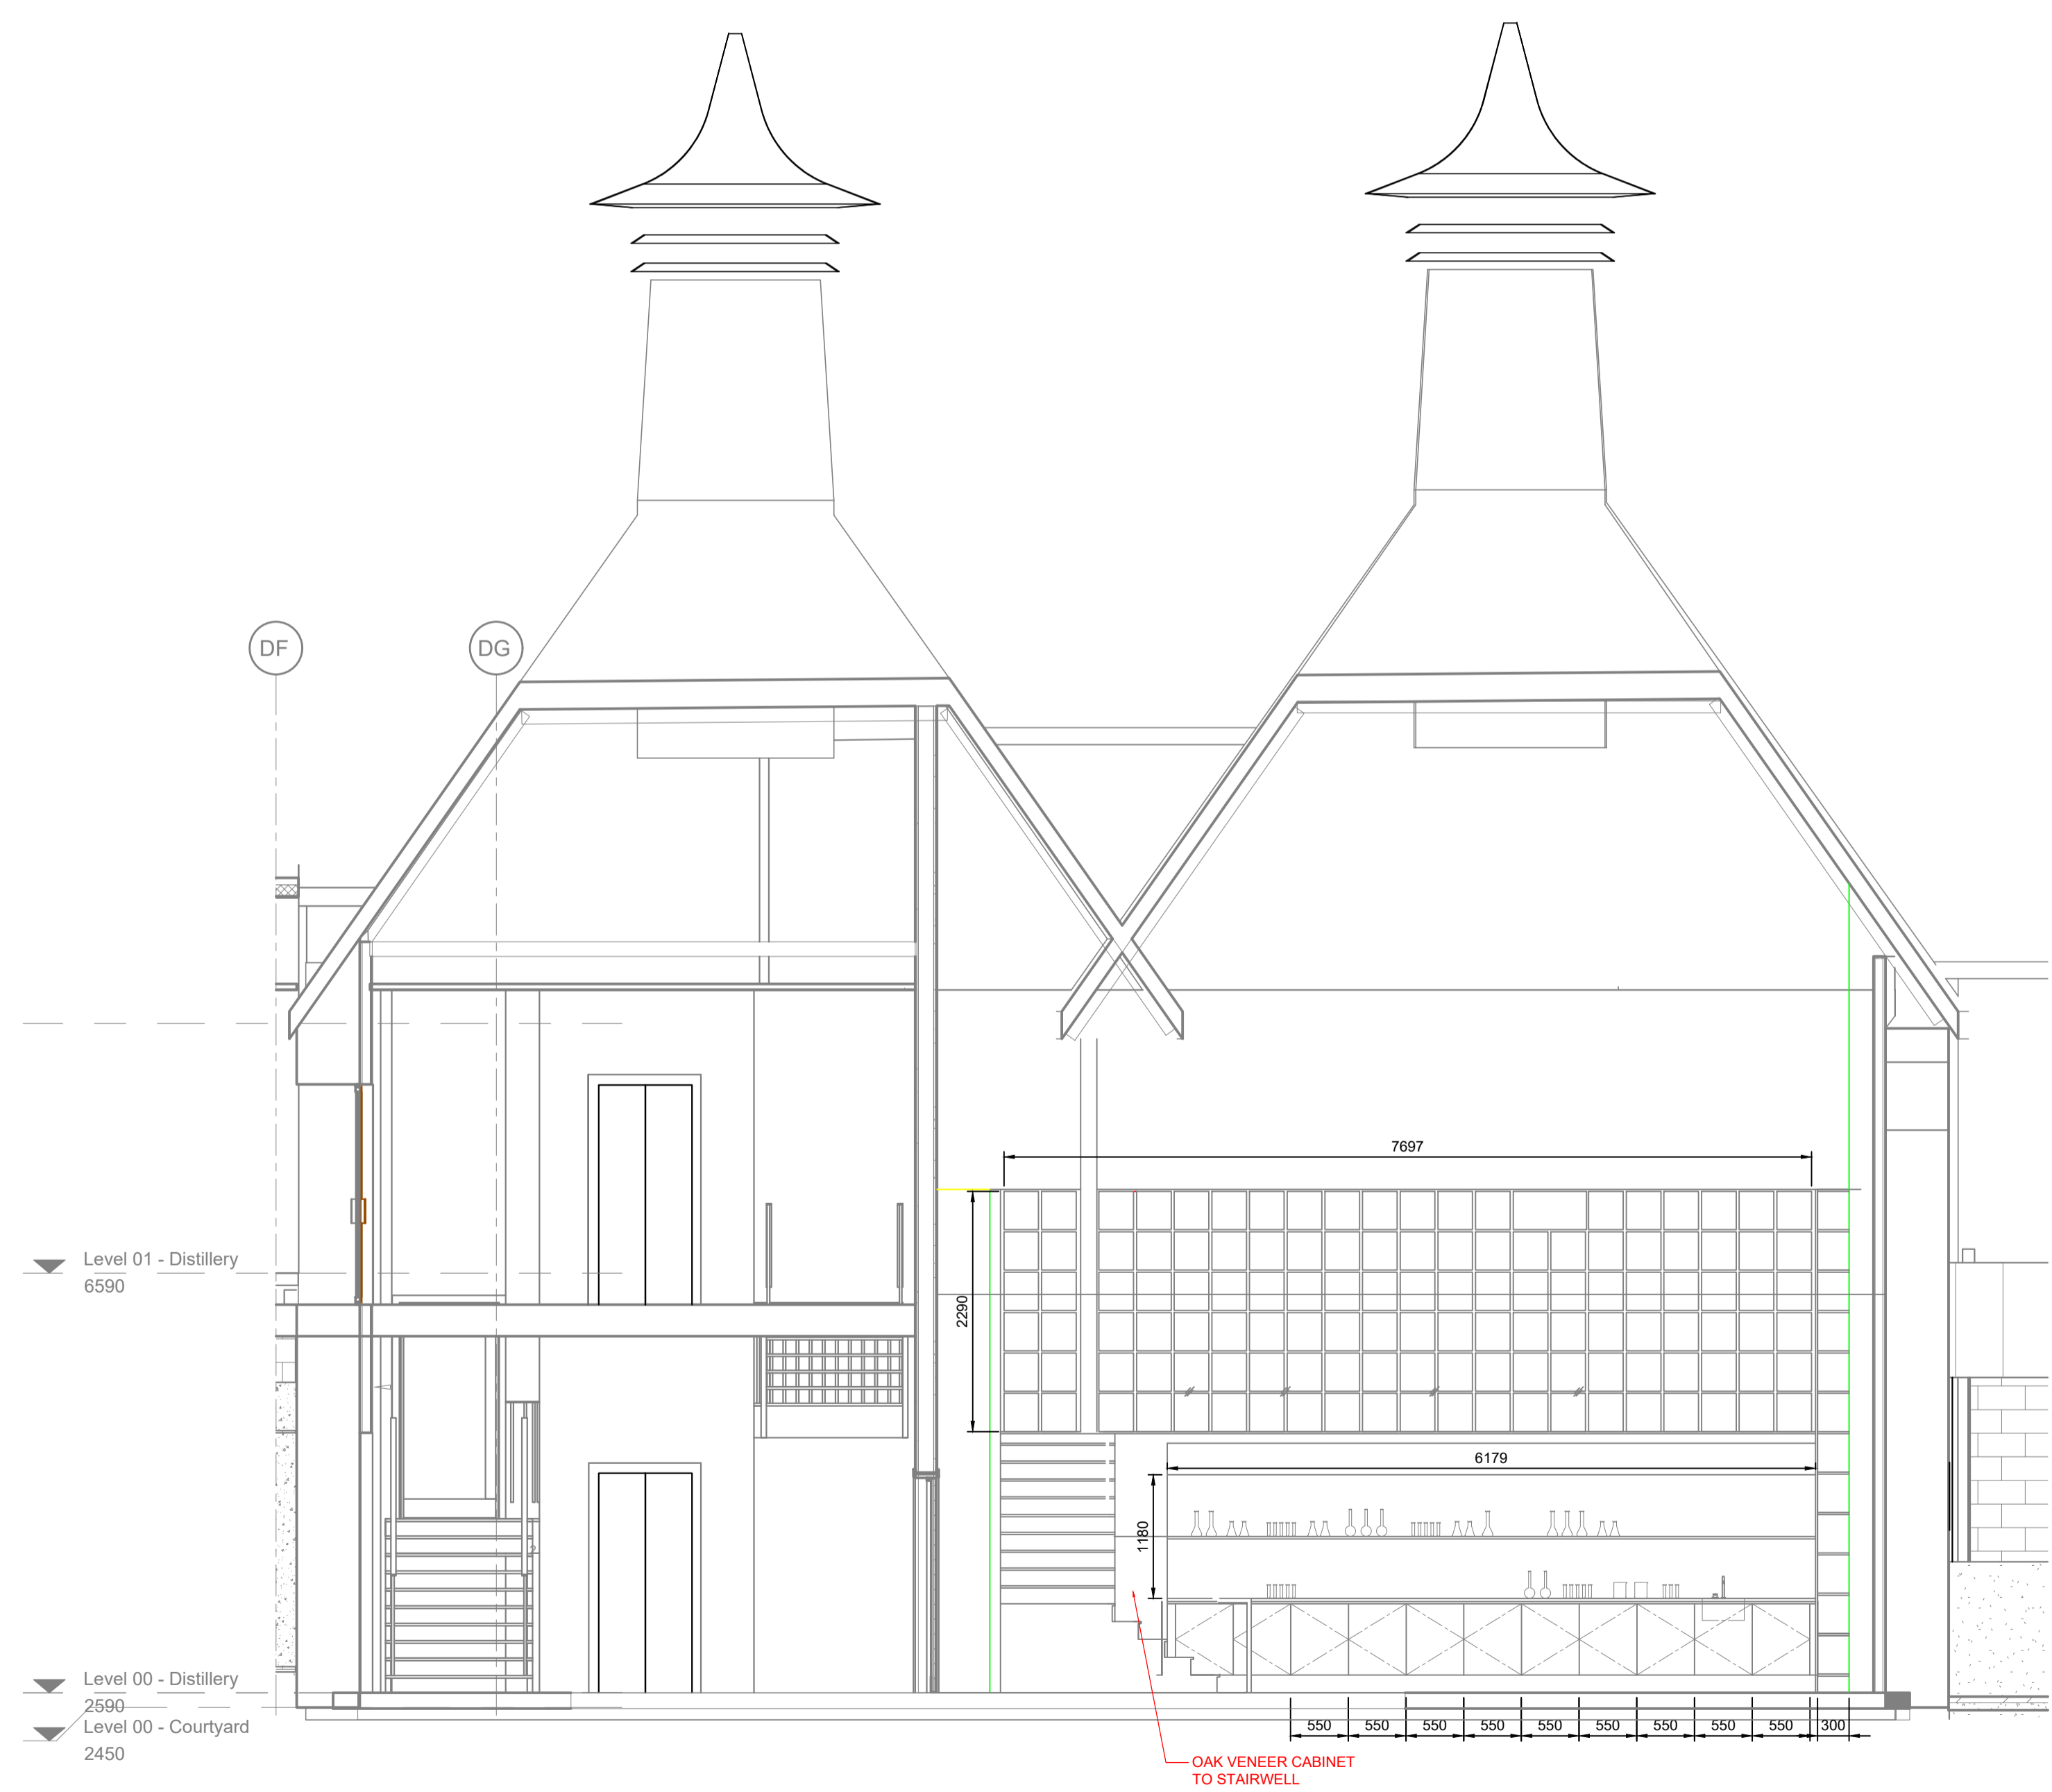

ELEVATION E (WALL CABINET)
1:50

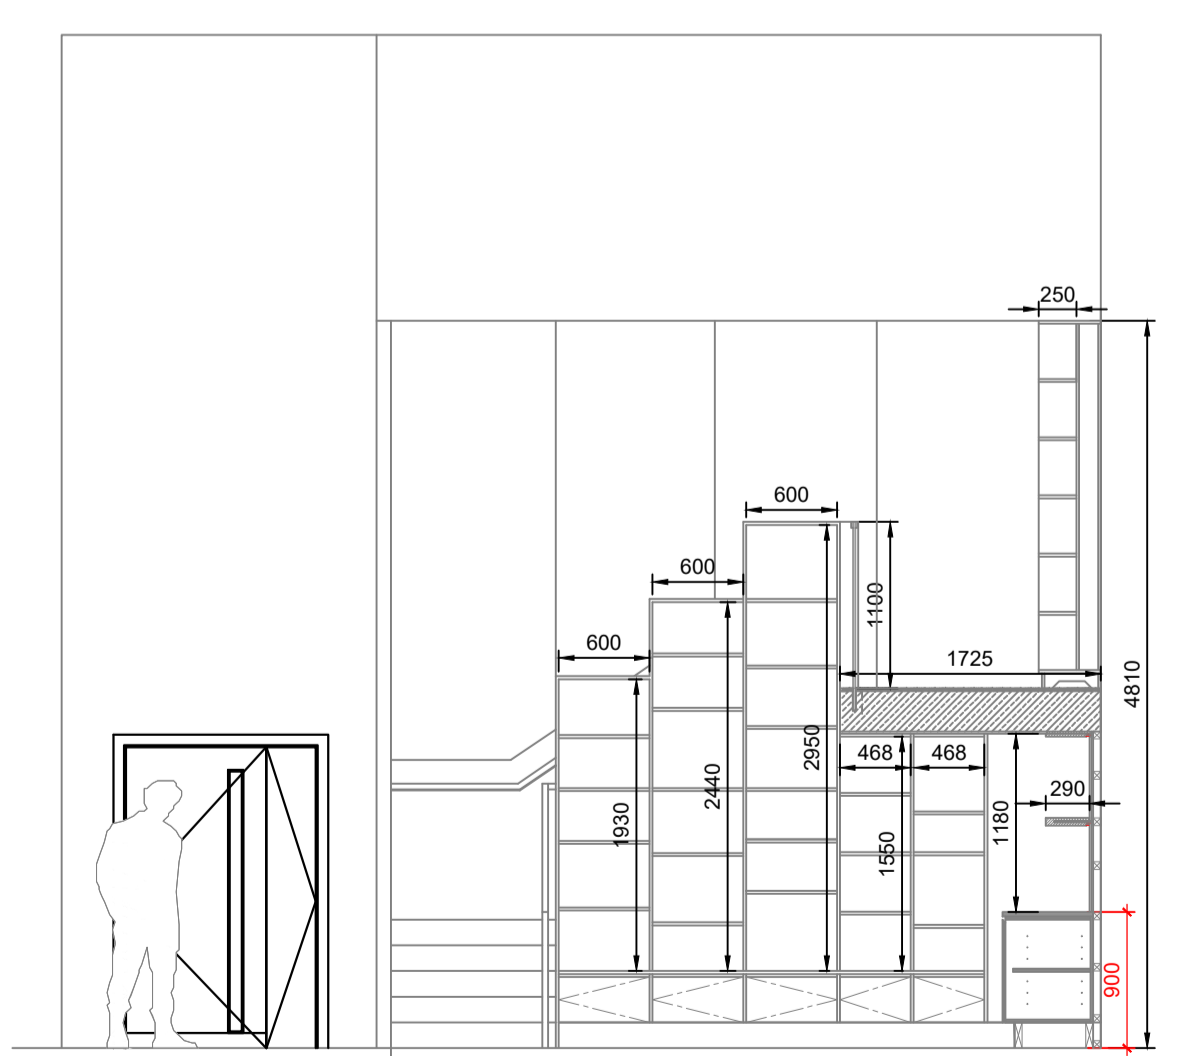

ELEVATION D (WALL CABINET)
1:50